



REVISION HISTORY			
REV	DESCRIPTION	DATE	APPROVED

# DETAIL "E"

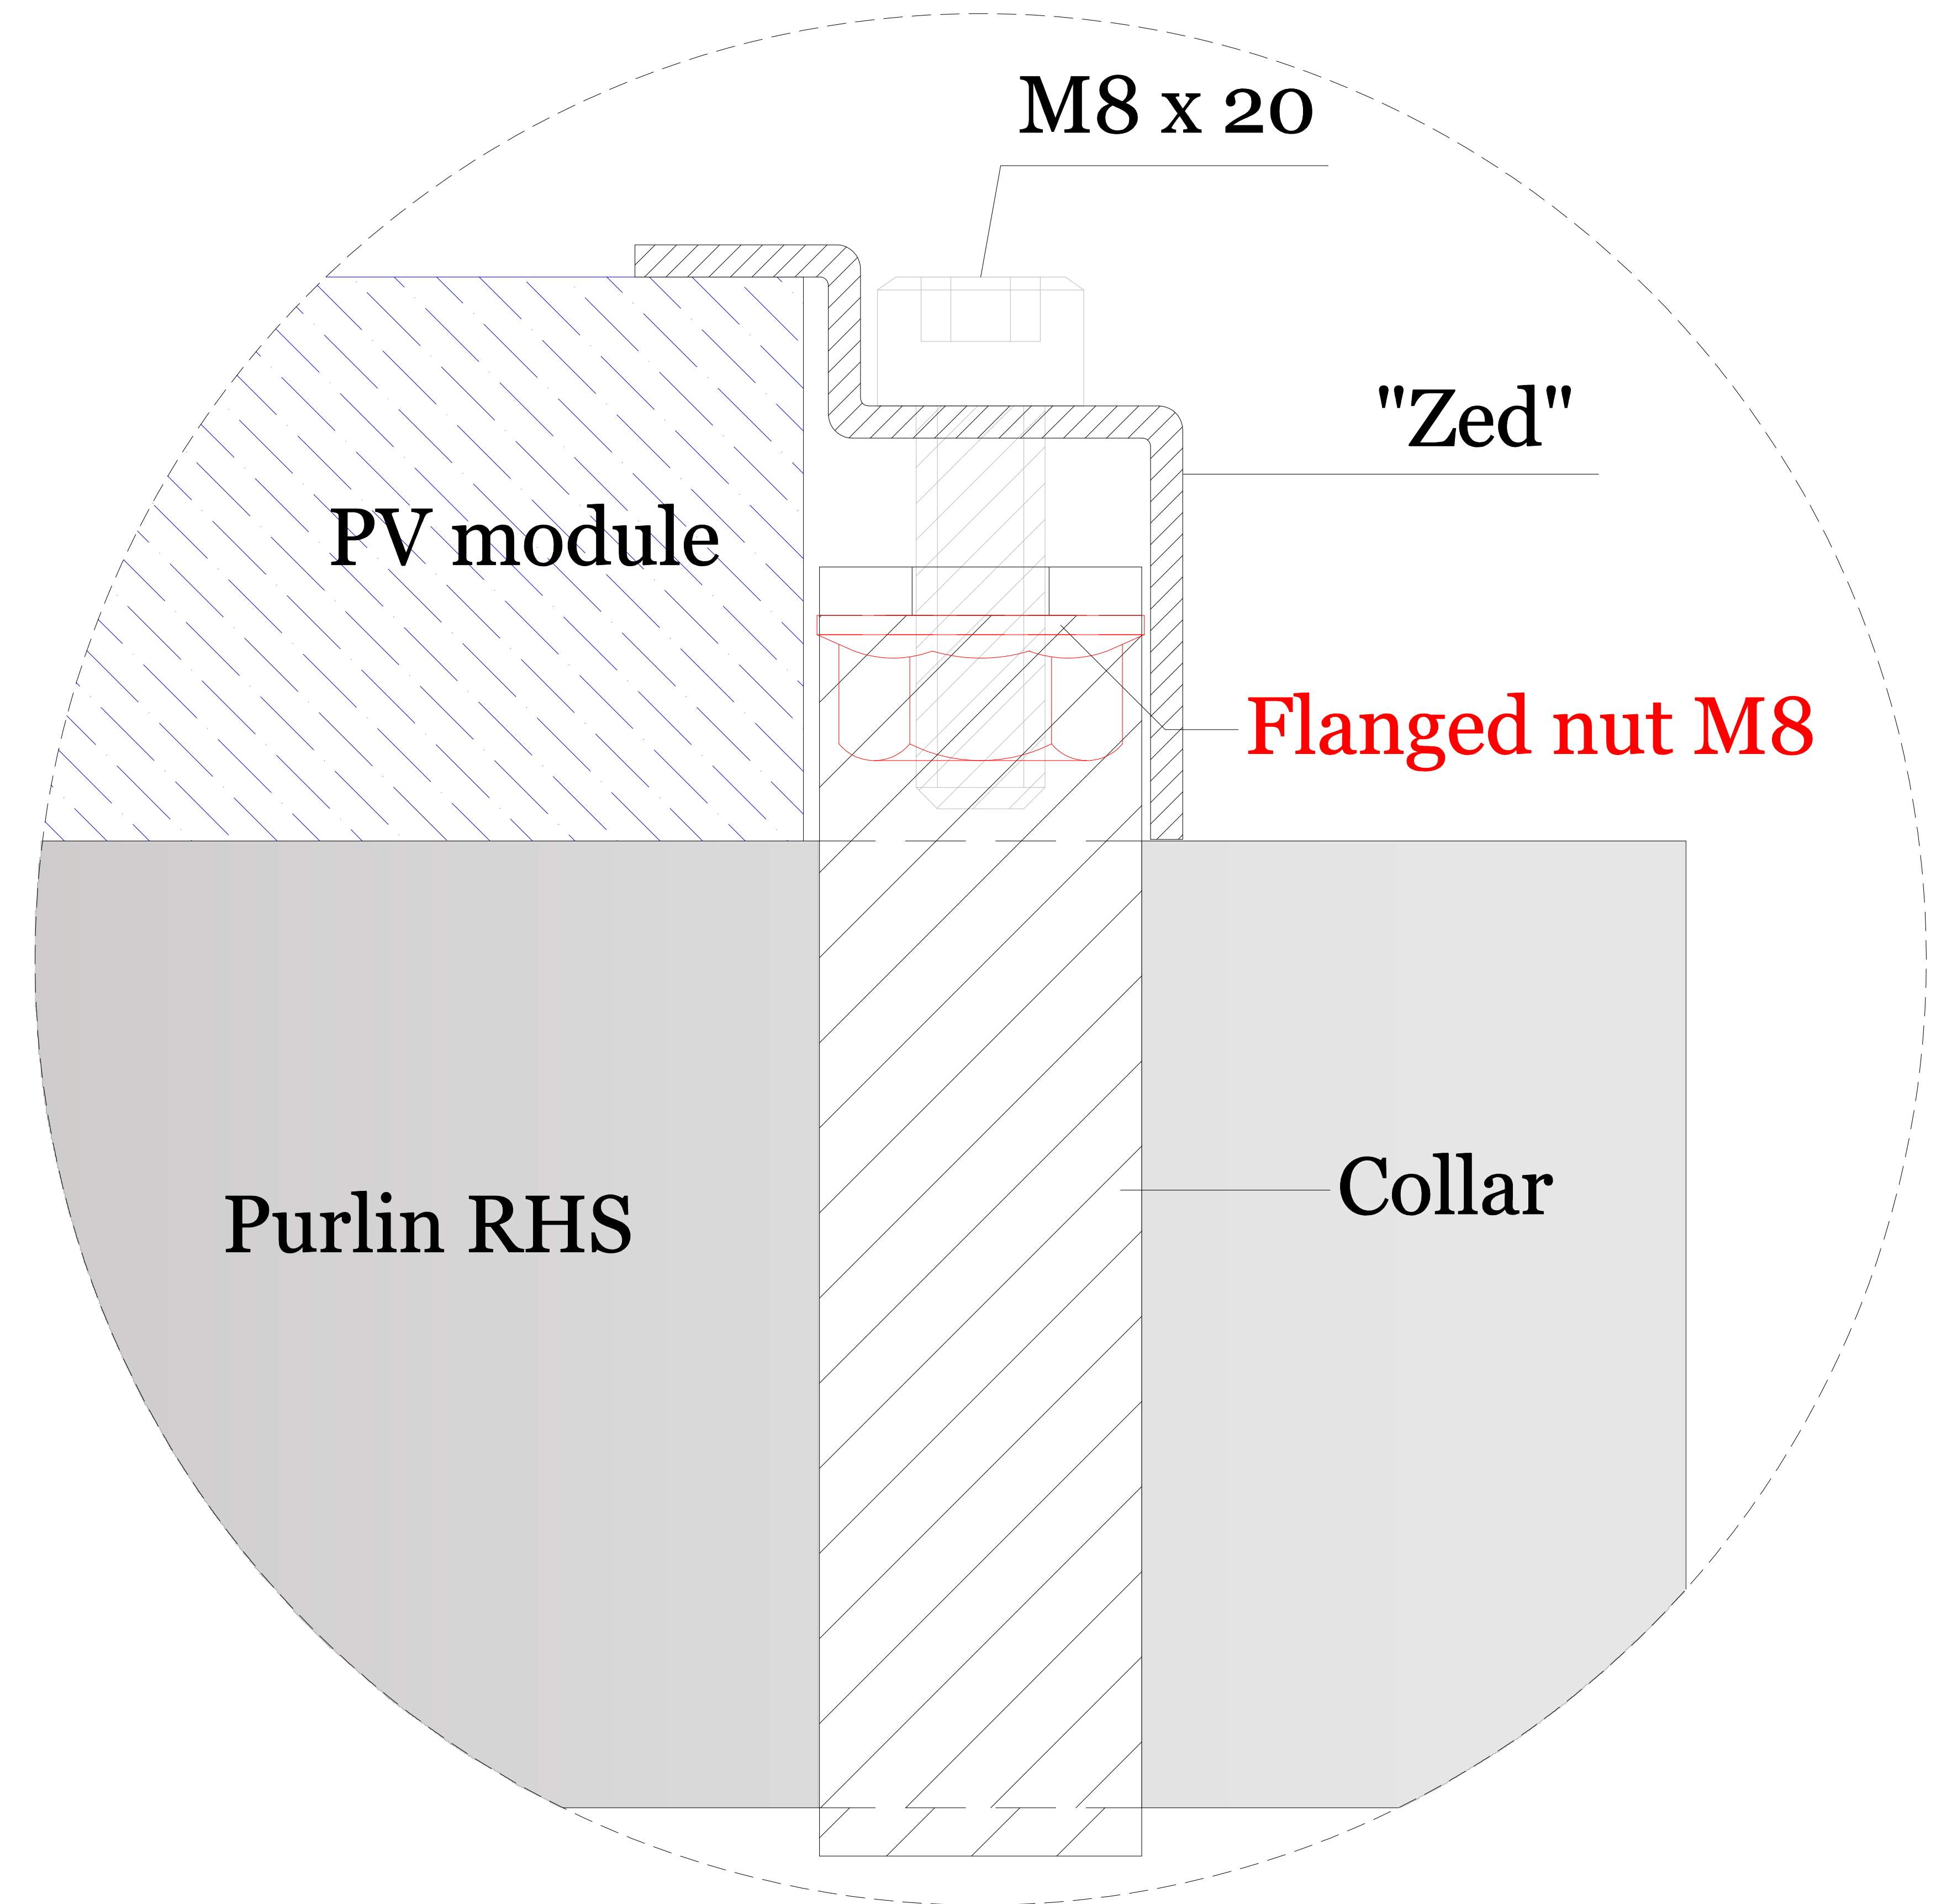

**PERMITTED TIGHTENING TORQUE OF MAX 10 Nm (to be verified with the prescriptions of the module manufacturer).**

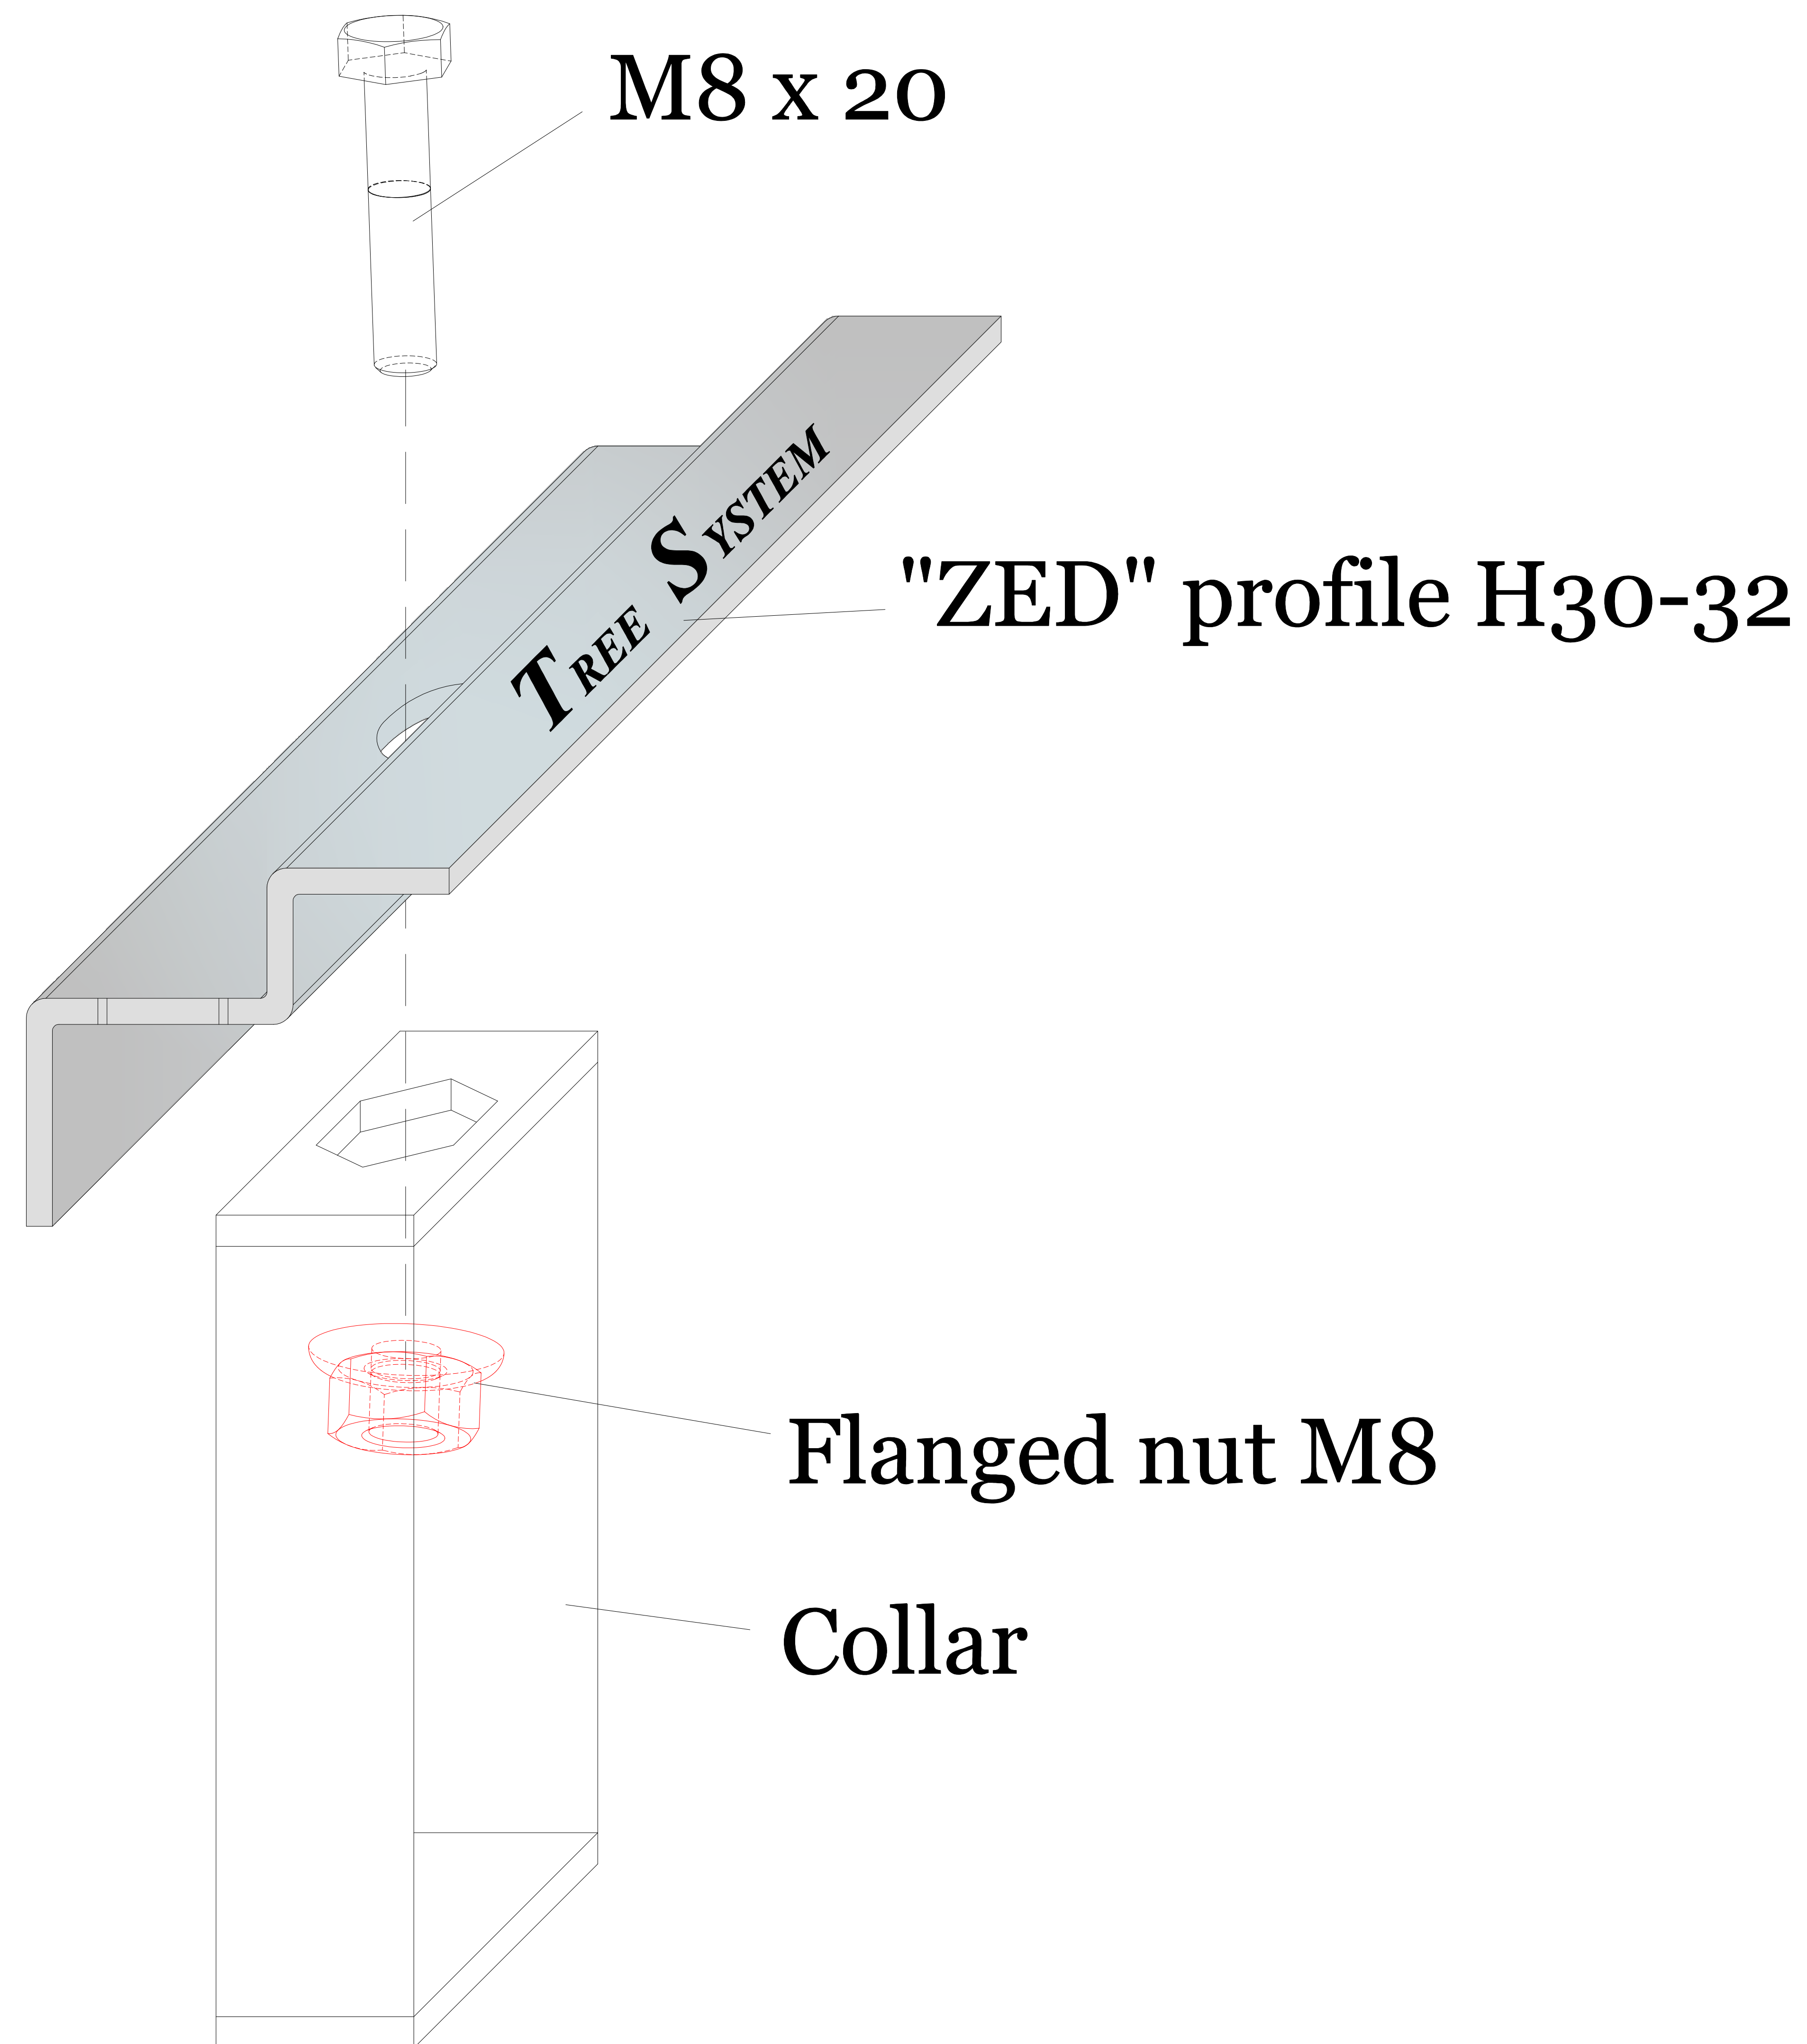

	NAME	DATE
DRAWN	M. T.	30/11/2020
CHECKED	E. B.	28/01/2021
MODIFIED	M. T.	03/03/2021



**TreeSystem s.r.l.**

Via Morano n°22, 35020, Pozzonovo (PD)  
Tel/Fax +390429773082



Netley North PV - Southampton  
5103 kWp PV power plant

TITLE  
Fastening for photovoltaic modules.

SIZE DWG NO **15** REV

SCALE: WEIGHT: SHEET